


# Site Plan – SED – Brookline Kirrane Pool – 3802 – 288.35 kW DC – 200 kW AC

60 Tappan St, Brookline, MA 02445

Utility: Eversource  
 Account #:  
 Meter #: 5119745

Scale: 1" = 50'-0"

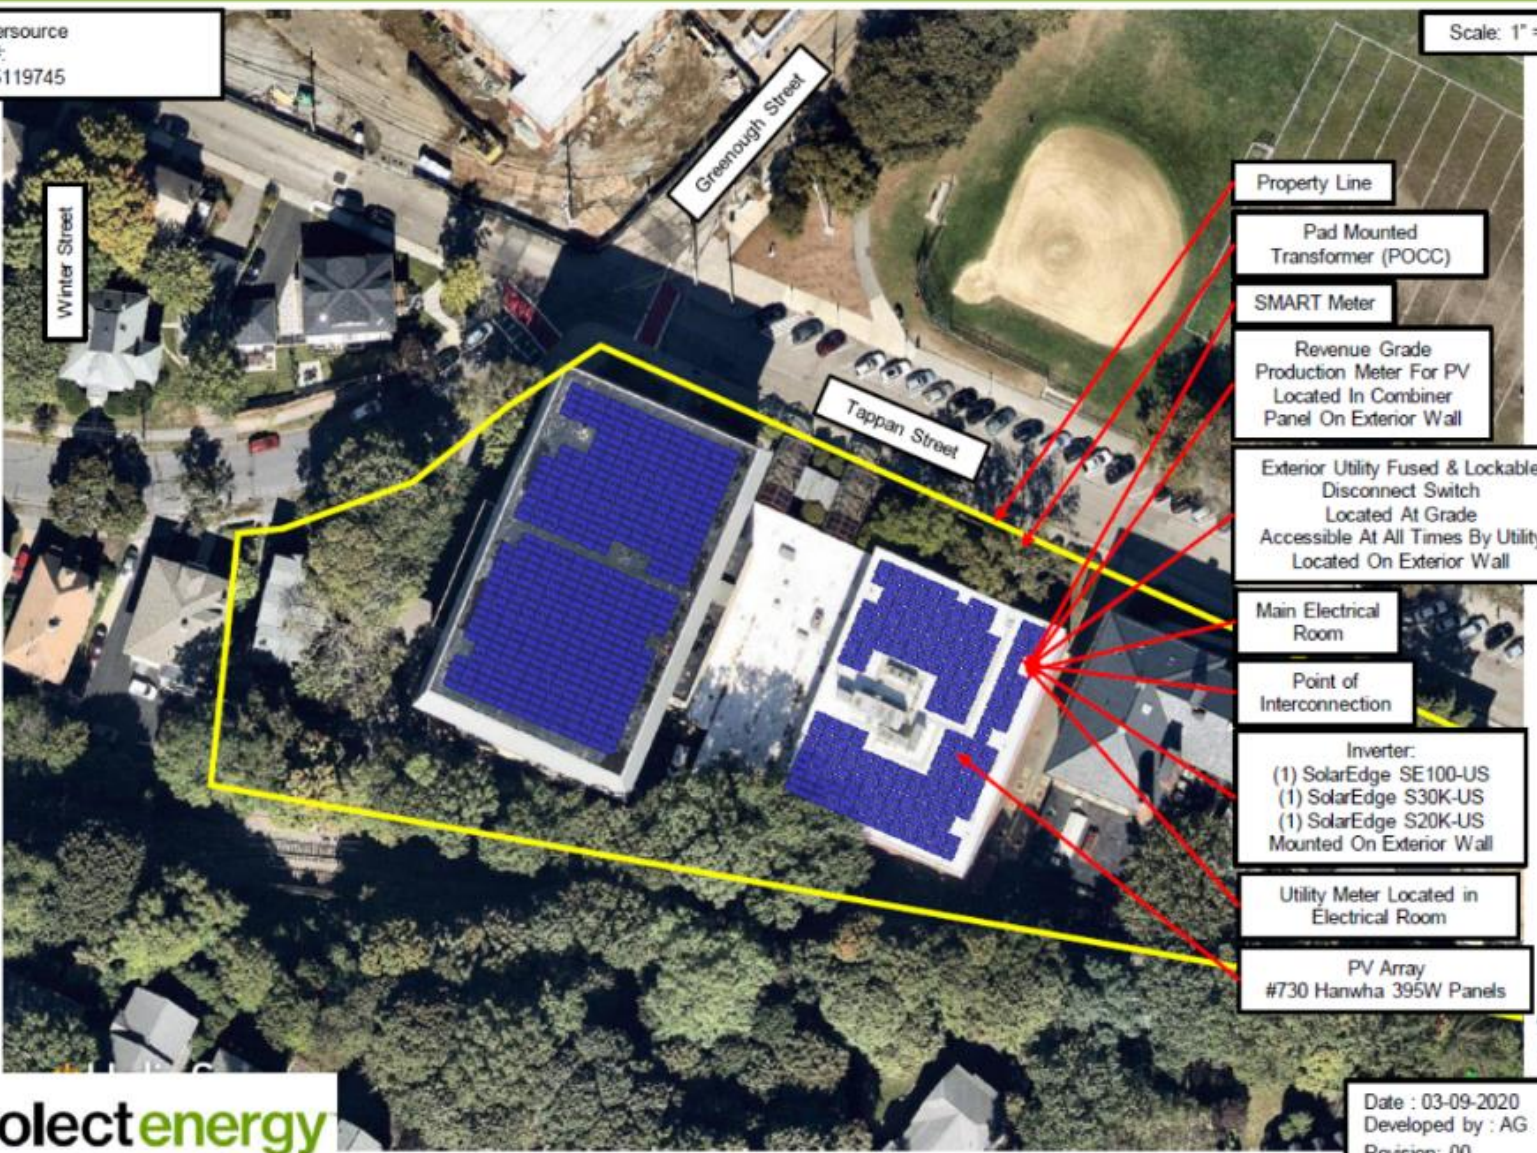

- Property Line
- Pad Mounted Transformer (POCC)
- SMART Meter
- Revenue Grade Production Meter For PV Located In Combiner Panel On Exterior Wall
- Exterior Utility Fused & Lockable Disconnect Switch Located At Grade Accessible At All Times By Utility Located On Exterior Wall
- Main Electrical Room
- Point of Interconnection
- Inverter:  
 (1) SolarEdge SE100-US  
 (1) SolarEdge S30K-US  
 (1) SolarEdge S20K-US  
 Mounted On Exterior Wall
- Utility Meter Located in Electrical Room
- PV Array  
 #730 Hanwha 395W Panels




# Site Plan – SED – Brookline Coolidge Corner School – 3805 – 249.245 kW DC – 200 kW AC

345 Harvard St, Brookline, MA 02446

Utility: Eversource  
Account #:  
Meter #: 5121444


Scale: 1" = 75'-0"

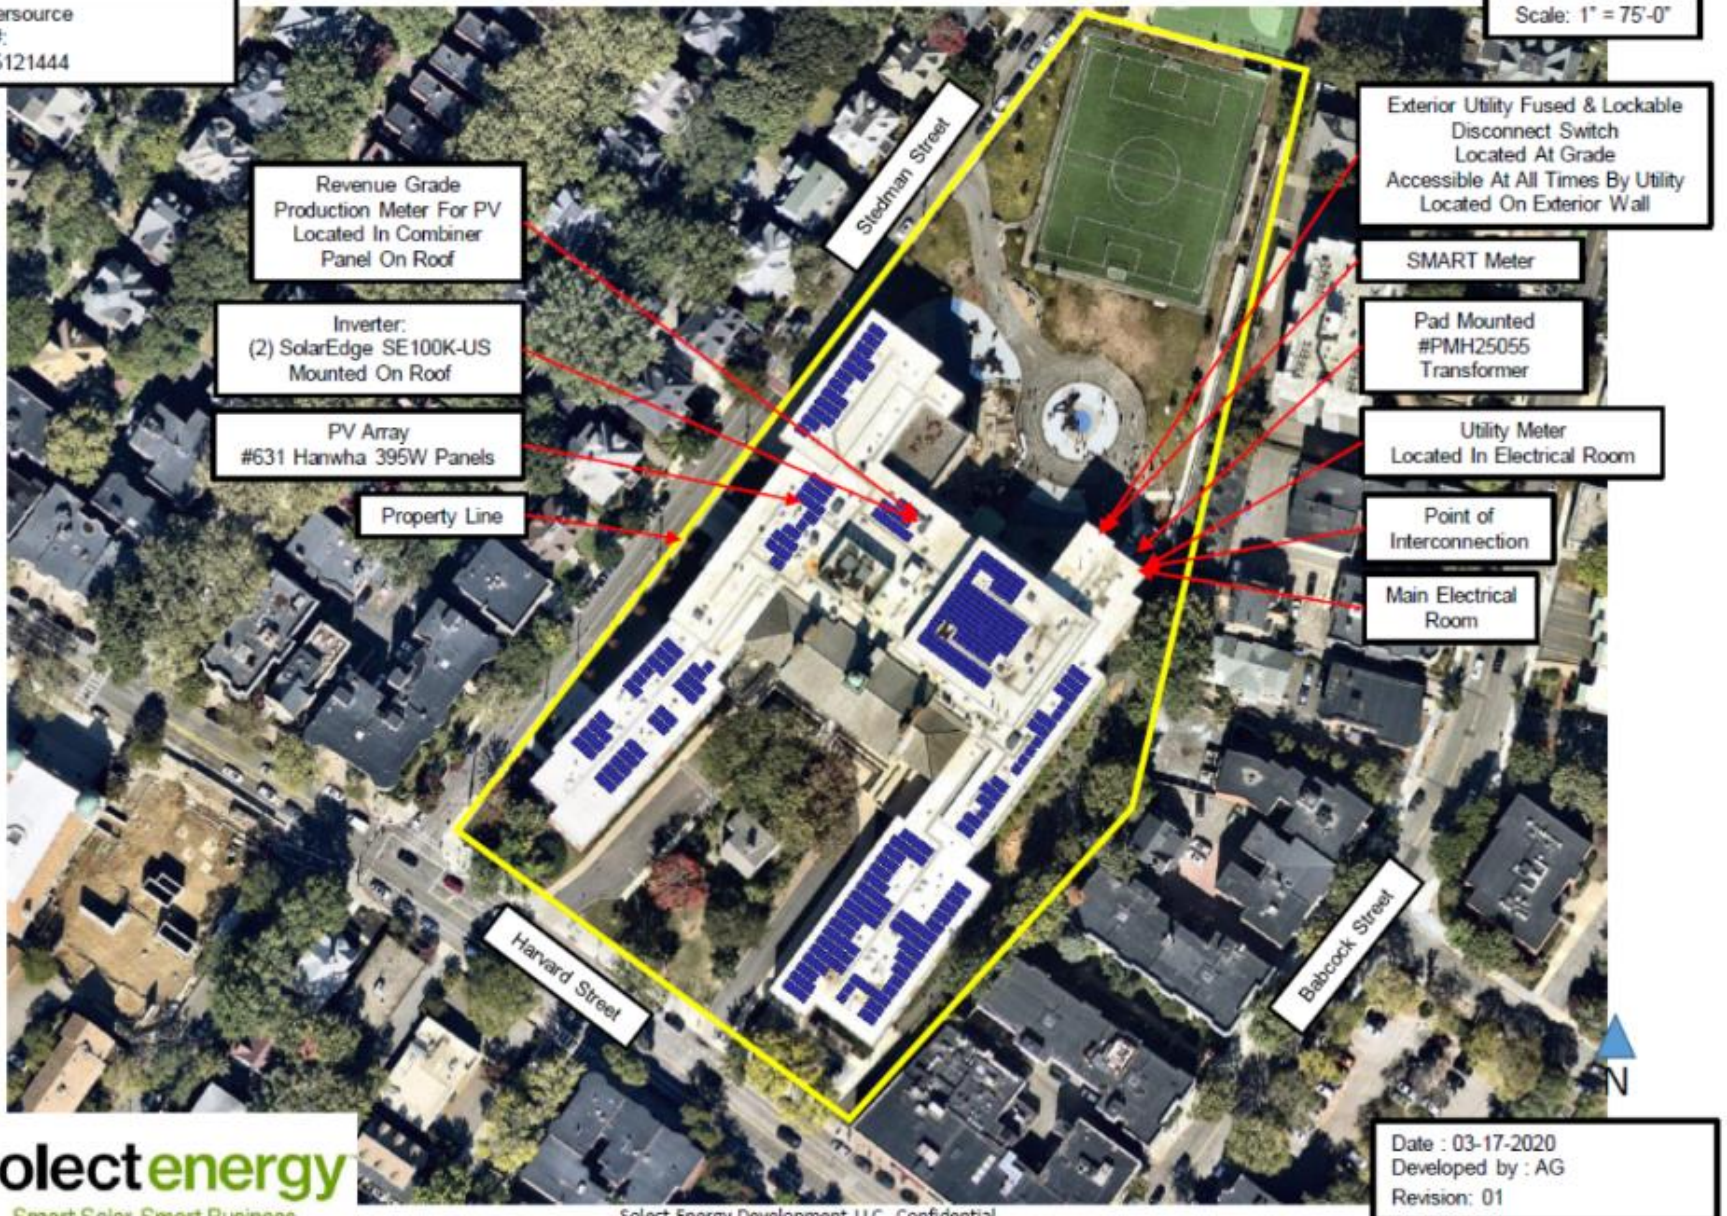



# Site Plan – SED - 3804 – Brookline High School – 146 kW DC – 100 kW AC

115 Greenough St, Brookline, MA 02445

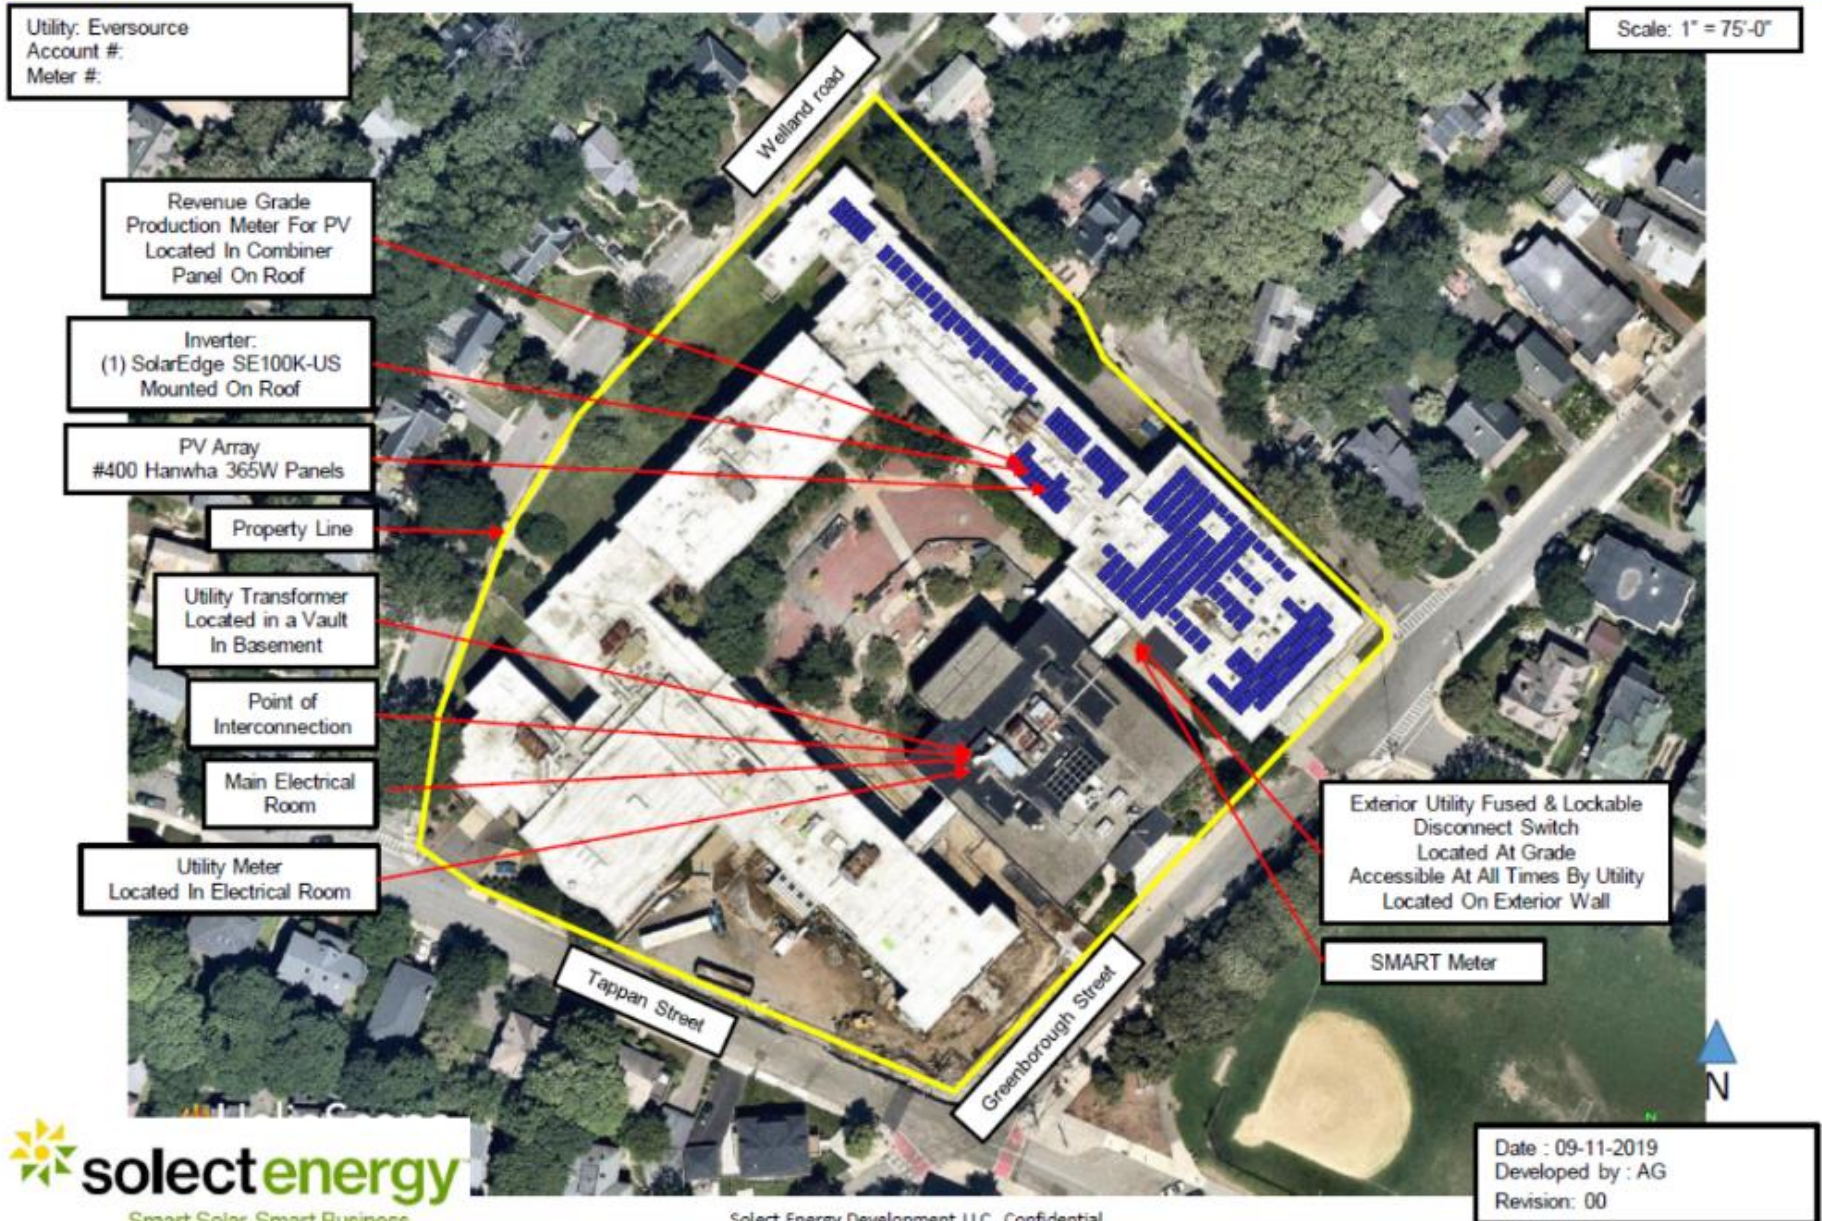



# Site Plan – SED – Brookline Runkle School – 3803 – 168.27 kW DC – 133.2 kW AC

50 Druce St, Brookline, MA 02445

Utility: Eversource  
Account #: 2848 909 0010  
Meter #: 5116620

Scale: 1" = 50'-0"

